



COTTAGE IN THE BLUE MOUNTAINS

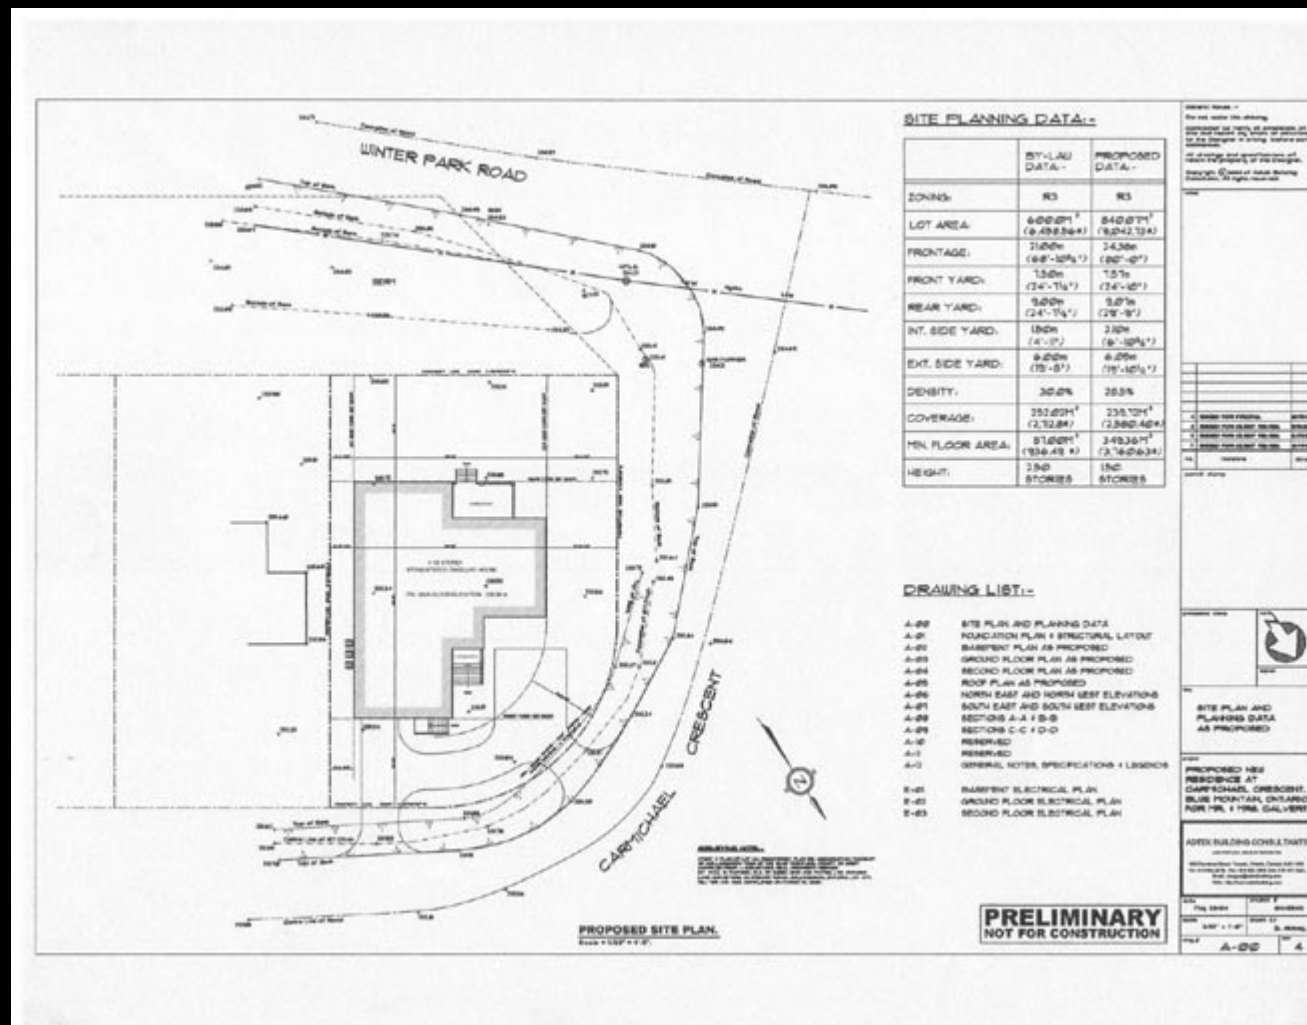

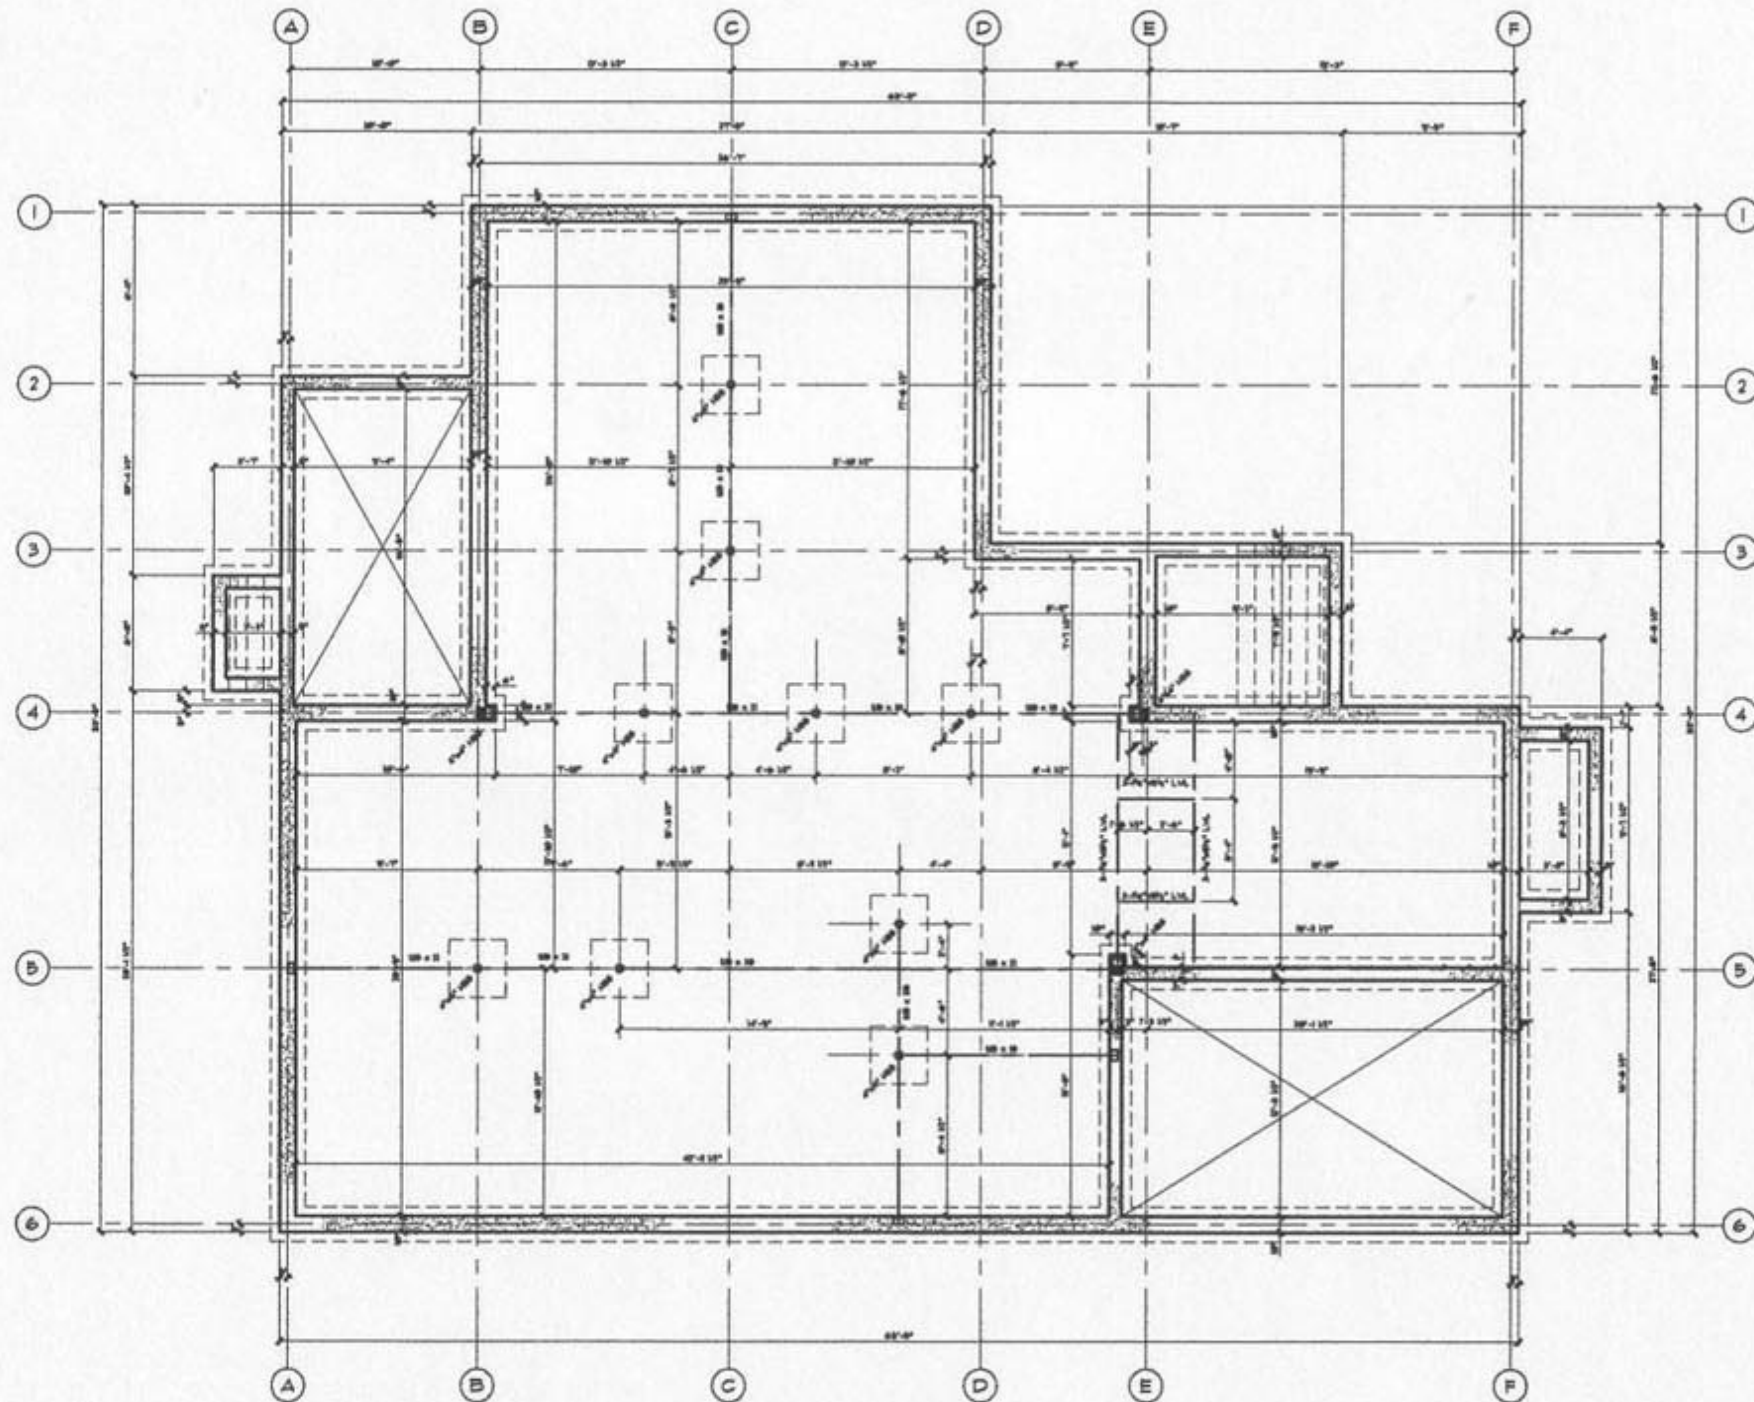

PROPOSED FOUNDATION PLAN.
Scale = 1/4" = 1'-0".

PRELIMINARY
NOT FOR CONSTRUCTION

General Notes :-
Do not scale this drawing.
Contractor to verify all dimensions on site and report any errors or omissions to the Designer in writing before work commences.
All drawings and specifications are the property of the Designer.
Copyright © 2004 of Adtek Building Consultants. All rights reserved.

revision		
no.	revision	date

ISSUED FOR PERMIT REVIEW

permit stamp

professional stamp




FOUNDATION PLAN & STRUCTURAL LAYOUT AS PROPOSED.

PROPOSED NEW RESIDENCE AT CARMICHAEL CRESCENT, BLUE MOUNTAIN, ONTARIO, FOR MR. & MRS. CALVERT.

ADTEK BUILDING CONSULTANTS
ARCHITECTURAL DESIGN & ENGINEERING
180 Cleveland Street, Toronto, Ontario, Canada, M4H 2Y6
Tel: 416 461-5276 Fax: 416 461-1963 Cell: 416 471-5002
Email: design@adtekbuilding.com Web: http://www.adtekbuilding.com

date	Sept. 07/04	project #	04/09-43
scale	1/4" = 1'-0"	drawn by	BL. Kibbey
des. #	A-01	rev	1

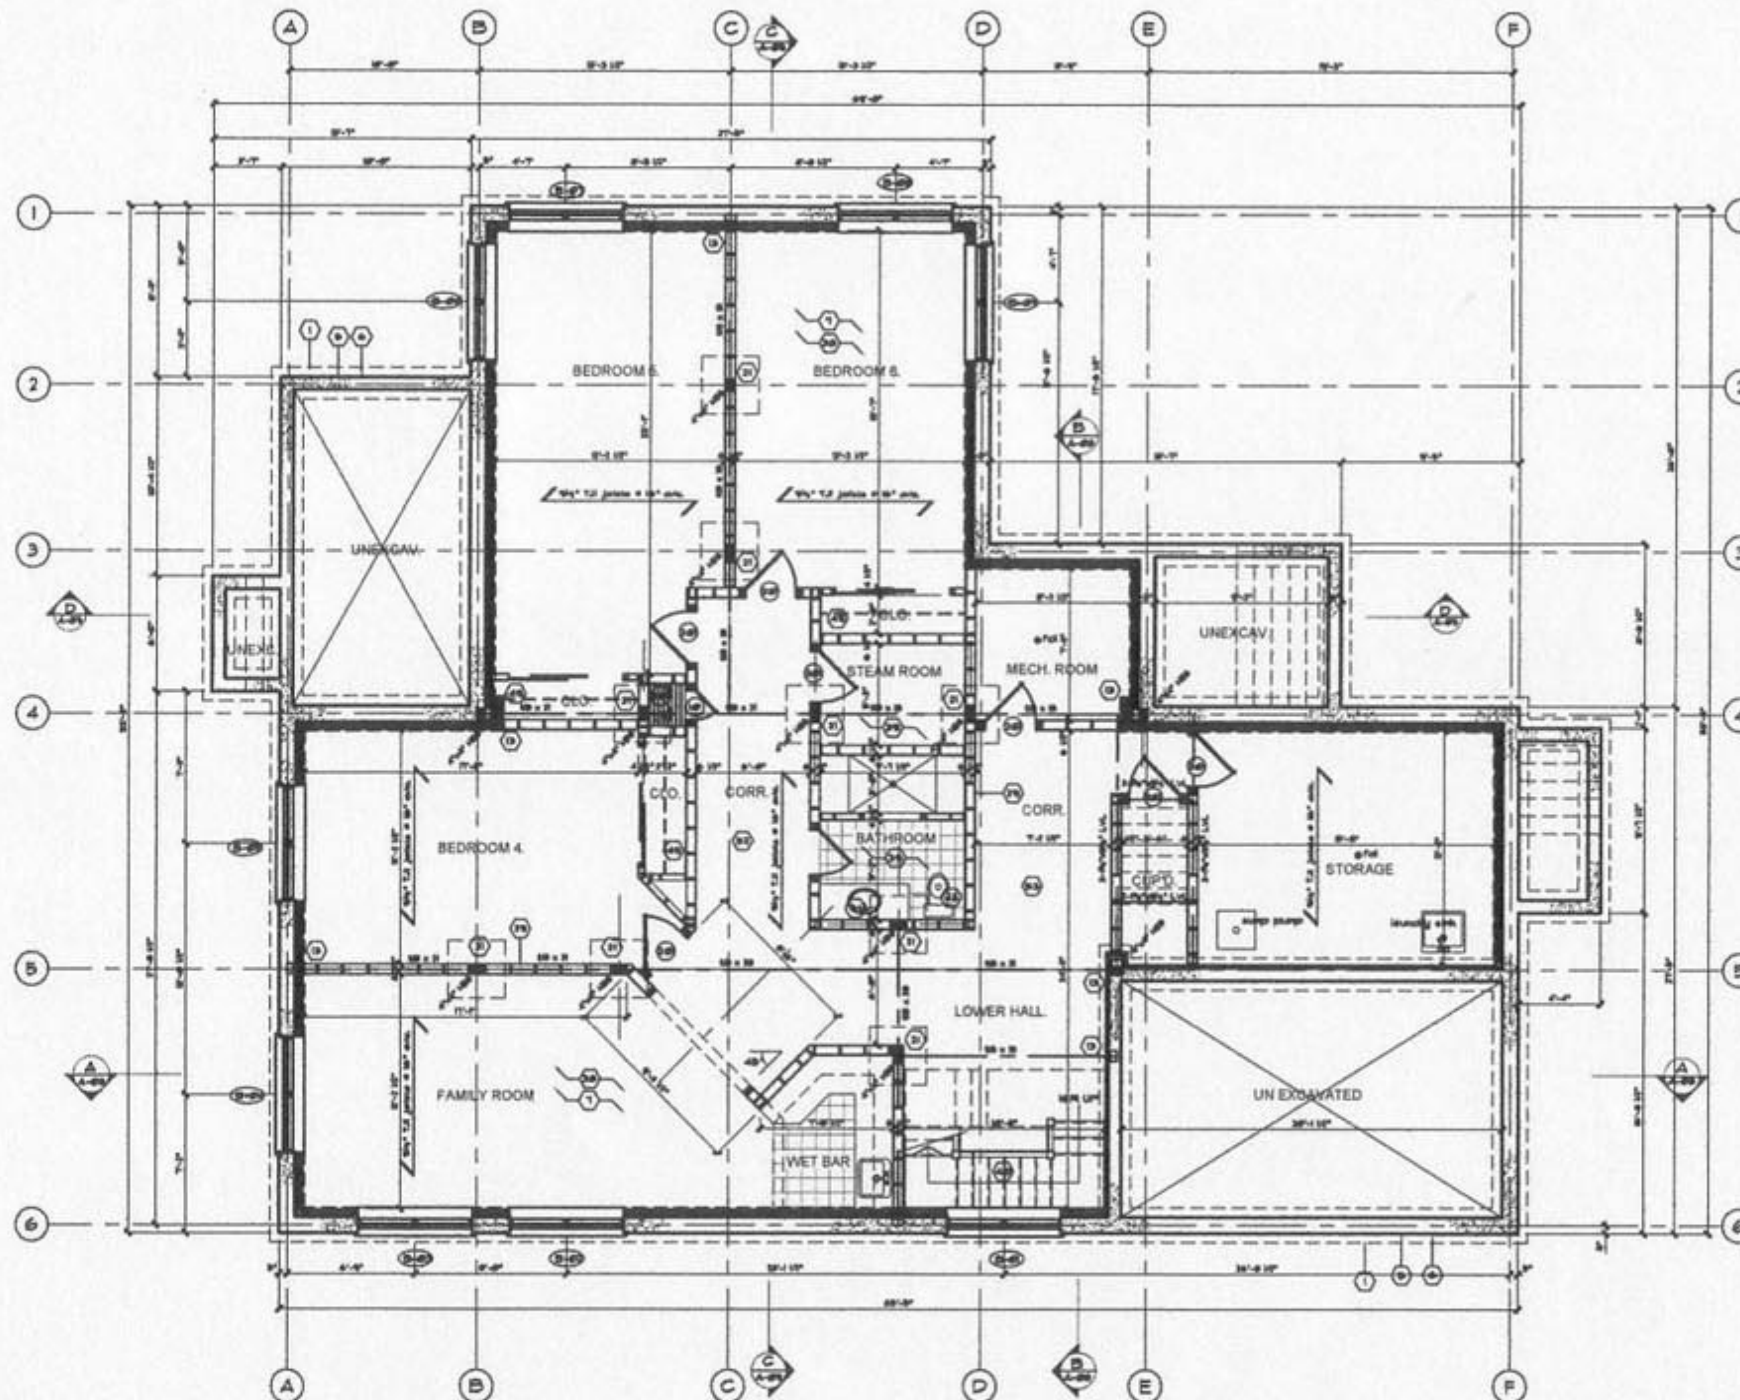

PROPOSED BASEMENT PLAN.
Scale = 1/4" = 1'-0".

PRELIMINARY
NOT FOR CONSTRUCTION

General Notes :-
Do not scale this drawing.
Contractor to verify all dimensions on site and report any errors or omissions to the Designer in writing before work commences.
All drawings and specifications will remain the property of the Designer.
Copyright © 2004 of Adtek Building Consultants. All rights reserved.

revisions		
no.	revisions	date
4	ISSUED FOR PROPOSAL	04/05/04
3	ISSUED FOR CLIENT REVIEW	03/04/04
2	ISSUED FOR CLIENT REVIEW	04/04/04
1	ISSUED FOR CLIENT REVIEW	04/04/04

permit stamp

professional stamp

North

align


THIS

BASEMENT PLAN
A8
PROPOSED

PROJECT

PROPOSED NEW RESIDENCE AT CARMICHAEL CRESCENT, BLUE MOUNTAIN, ONTARIO, FOR MR. & MRS. CALVERT.

ADTEK BUILDING CONSULTANTS
4001107/108/109/110/2591/25

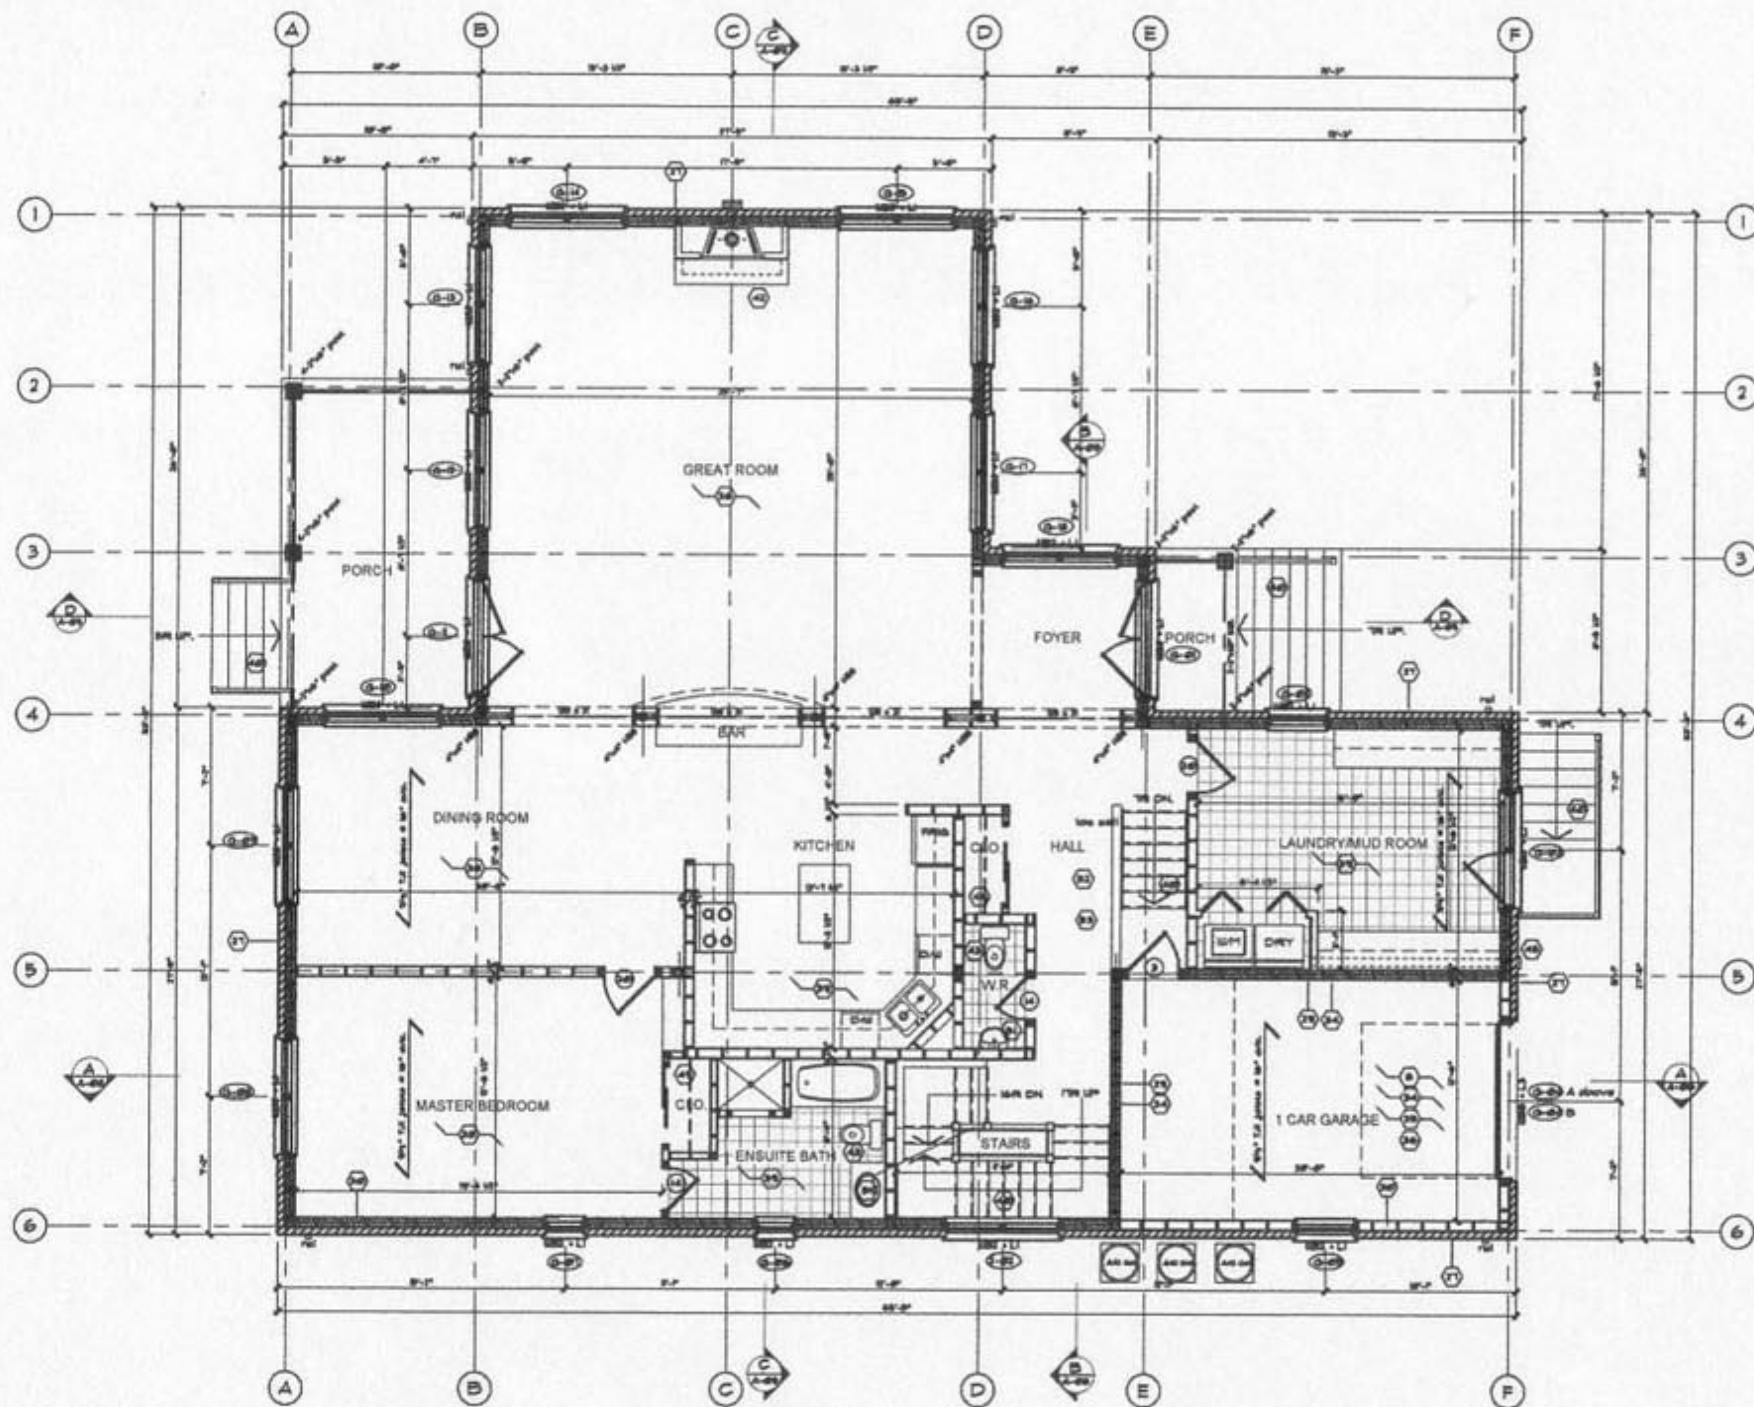

PROPOSED GROUND FLOOR PLAN.
Scale = 1/8" = 1'-0".

PRELIMINARY
NOT FOR CONSTRUCTION

General Notes :-
Do not scale this drawing.
Contractor to verify all dimensions on site and report any errors or omissions to the Designer in writing before work commences.
All drawings and specifications will remain the property of the Designer.
Copyright © 2004 of Adtek Building Consultants. All rights reserved.

Notes

4	ISSUED FOR PERMITS	06/28/04
3	ISSUED FOR CLIENT REVIEW	06/18/04
2	ISSUED FOR CLIENT REVIEW	06/09/04
1	ISSUED FOR CLIENT REVIEW	06/04/04

no.	revisions	date
-----	-----------	------

permit stamp

professional stamp




GROUND FLOOR PLAN AS PROPOSED

PROJECT
PROPOSED NEW RESIDENCE AT CARMICHAEL CRESCENT, BLUE MOUNTAIN, ONTARIO, FOR MR. & MRS. CALVERT.

ADTEK BUILDING CONSULTANTS
ARCHITECTURAL DESIGN & TECHNICAL
160 Cleveland Road, Toronto, Ontario, Canada, M8S 2W5
Tel: 416 602 5275, Fax: 416 583 1363, Cell: 416 571 6853
Email: adtek@adtekbuilding.com
Web: http://www.adtekbuilding.com

date	June 18/04	project #	04-05-43
scale	1/4" = 1'-0"	drawn by	SS. Alsbury
des.g	A-03	rev	4

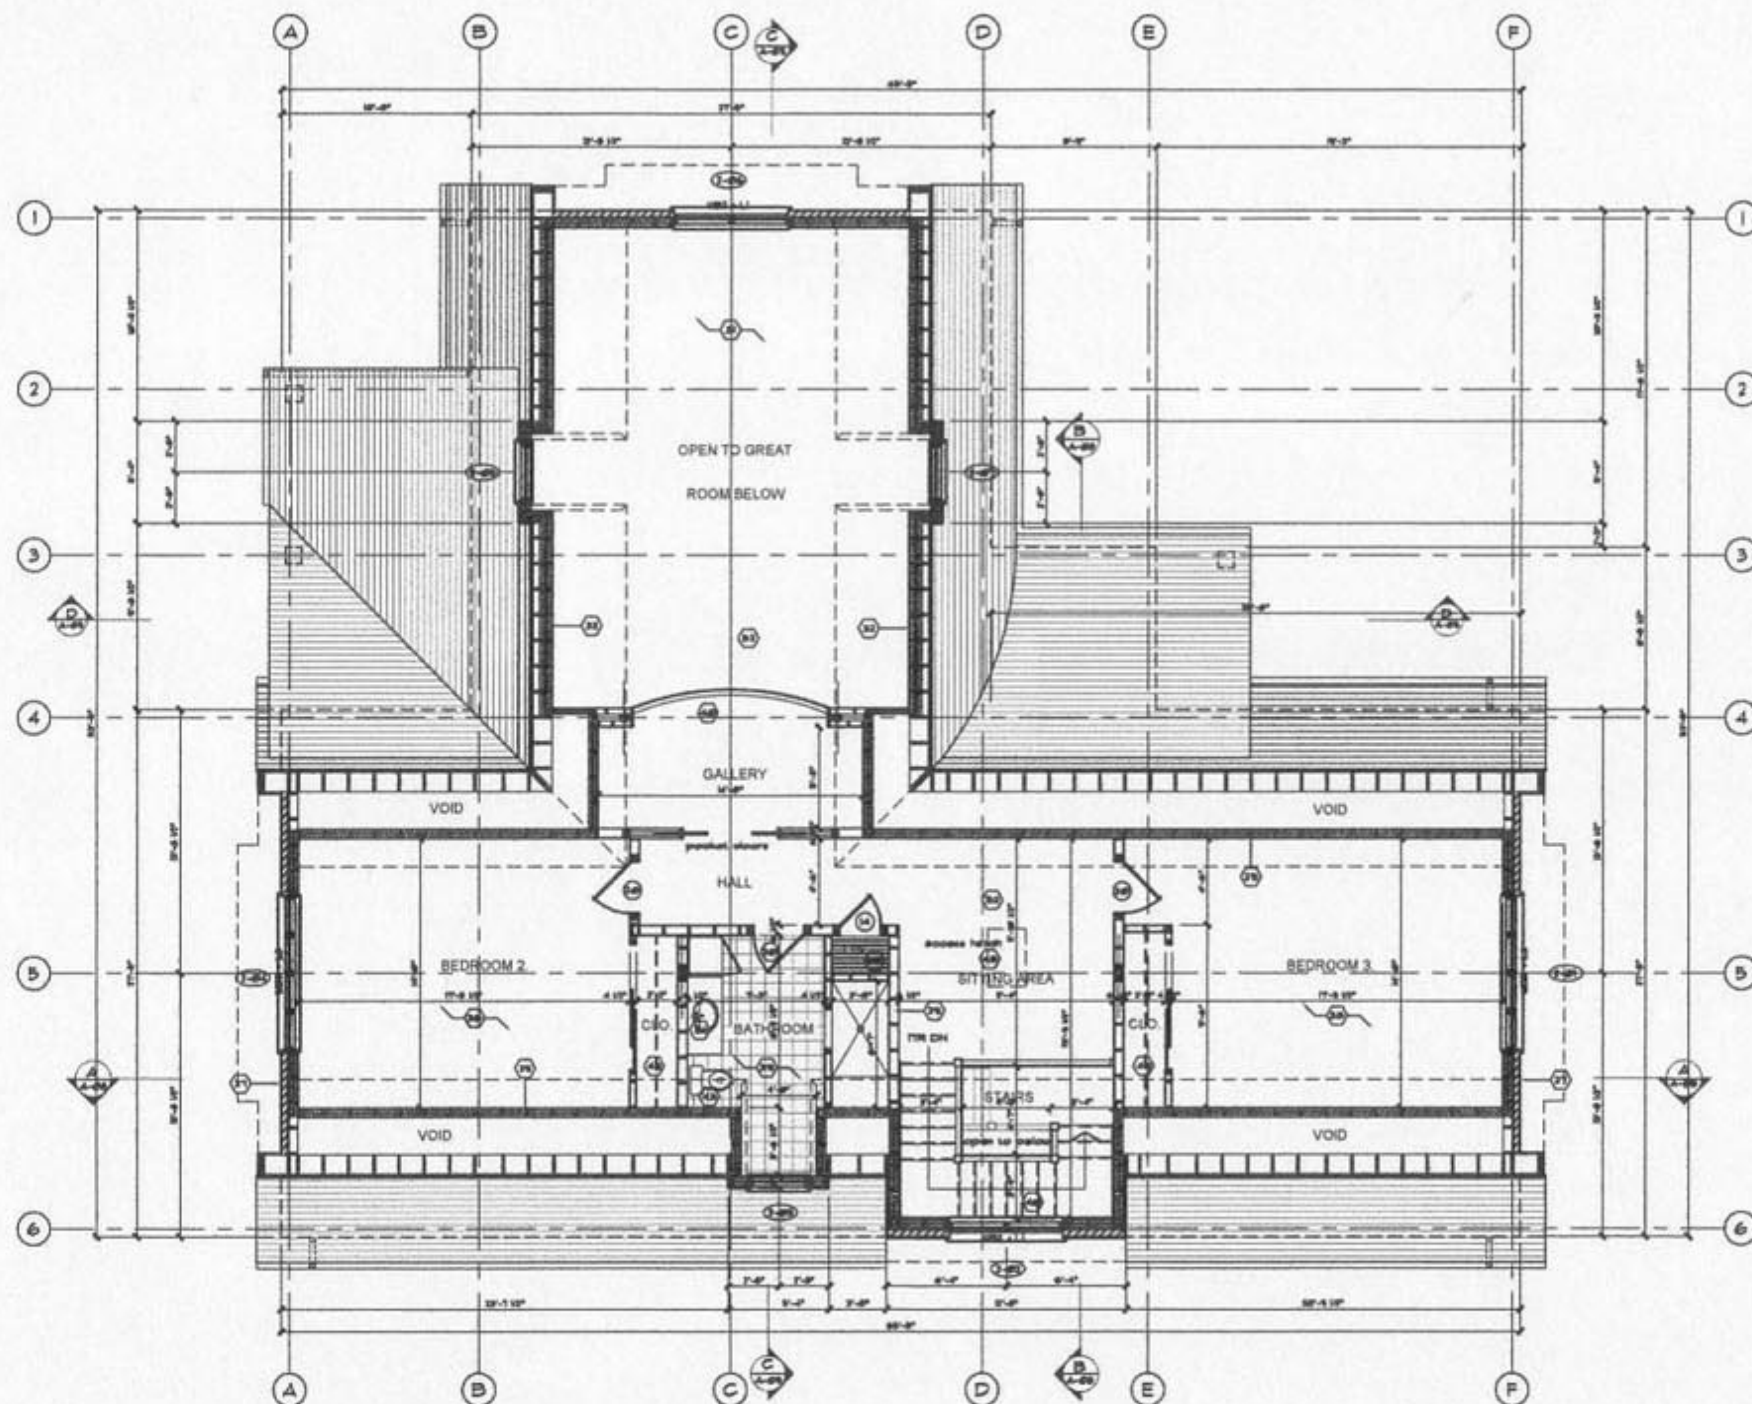

PROPOSED SECOND FLOOR PLAN..
Scale = 1/4" = 1'-0".

PRELIMINARY
NOT FOR CONSTRUCTION

General Notes :-
Do not scale this drawing.
Contractor to verify all dimensions on site and report any errors or omissions to the Designer in writing before work commences.
All drawings and specifications will remain the property of the Designer.
Copyright © 2004 of Adtek Building Consultants. All rights reserved.

notes

4	ISSUED FOR PERMITS	10/28/04
3	ISSUED FOR CLIENT REVIEW	10/28/04
2	ISSUED FOR CLIENT REVIEW	10/28/04
1	ISSUED FOR CLIENT REVIEW	10/28/04

no.	revisions	date
-----	-----------	------

permit stamp

professional stamp




**SECOND FLOOR
PLAN AS
PROPOSED**

project
**PROPOSED NEW
RESIDENCE AT
CARMICHAEL CRESCENT,
BLUE MOUNTAIN, ONTARIO,
FOR MR. & MRS. CALVERT.**

ADTEK BUILDING CONSULTANTS
ARCHITECTURAL DESIGN & TECHNOLOGY
360 Cleveland Street, Toronto, Ontario, Canada, M4S 1B9
Tel: +1 416 593 5276, Fax: +1 416 593 1200, Cell: +1 416 571 9222
Email: design@adtekbuilding.com
Web: http://www.adtekbuilding.com

date	June 15/04	project #	04-100-43
scale	1/4" = 1'-0"	drawn by	B. Alkaway
dwg. #	A-04	rev	4

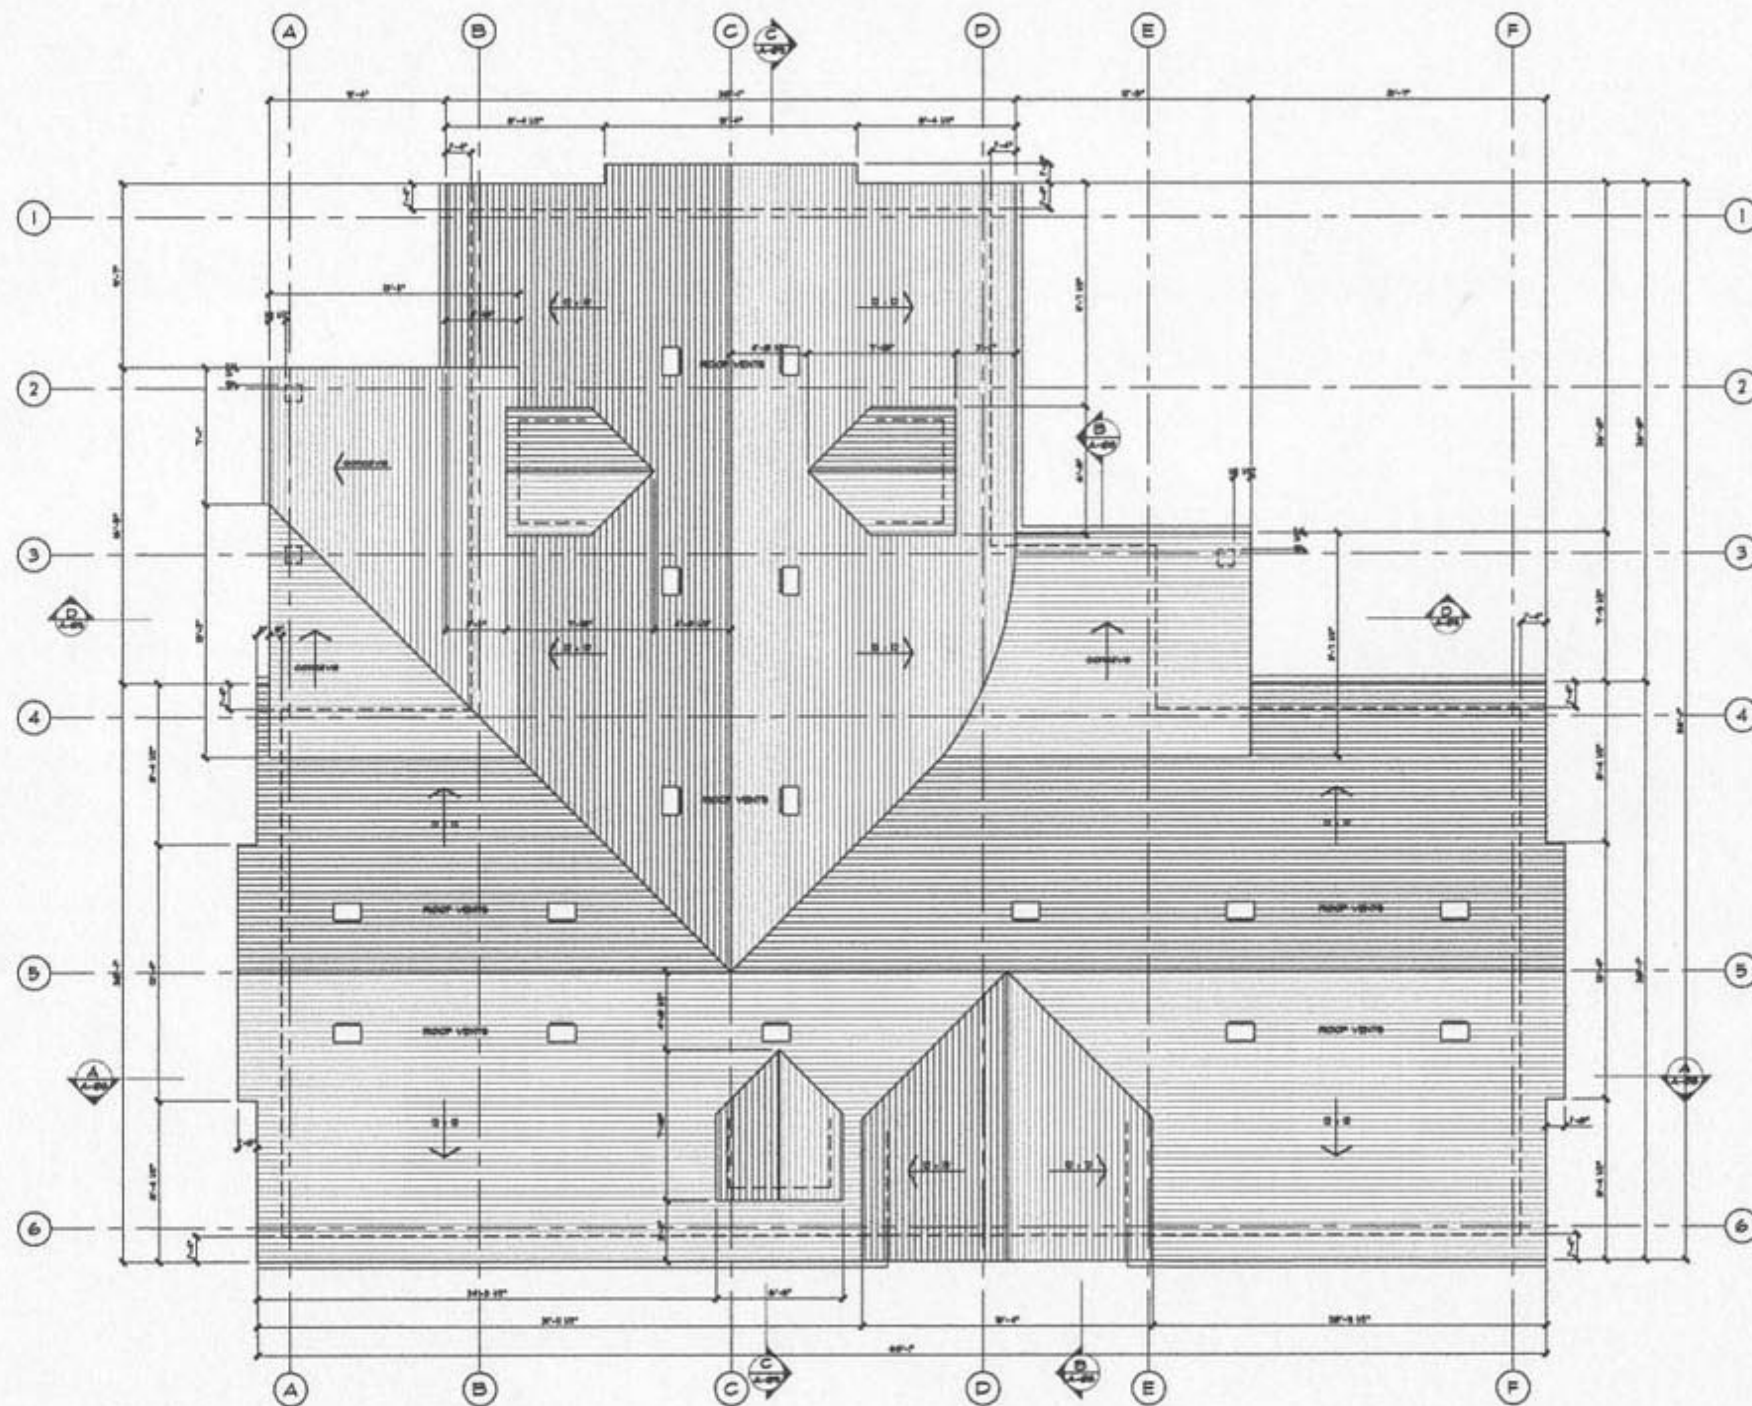

PROPOSED ROOF PLAN.
Scale = 1/4" = 1'-0".

PRELIMINARY
NOT FOR CONSTRUCTION

General Notes :-
Do not scale this drawing.
Contractor to verify all dimensions on site and report any errors or omissions to the Designer in writing before work commences.
All drawings and specifications will remain the property of the Designer.
Copyright © 2004 of Adtek Building Consultants. All rights reserved.

Notes:

4	ISSUED FOR PERMITS	6/25/04
3	ISSUED FOR CLIENT REVIEW	6/25/04
2	ISSUED FOR CLIENT REVIEW	6/25/04
1	ISSUED FOR CLIENT REVIEW	6/25/04

no.	revisions	date

permit stamp

professional stamp



Site

ROOF PLAN
AS
PROPOSED

Project
PROPOSED NEW
RESIDENCE AT
CARMICHAEL CRESCENT,
BLUE MOUNTAIN, ONTARIO.
FOR MR. & MRS. CALVERT.

ADTEK BUILDING CONSULTANTS
ARCHITECTURAL DESIGN & TECHNOLOGY
202 Cleveland Street, Toronto, Ontario, Canada M6E 2Y6
Tel: 416 533 8278 Fax: 416 533 1361 Cell: 416 571 9302
Email: adtek@adtekbldg.com
Web: http://www.adtekbldg.com

date	project #
June 25/04	04-05-43
scale	drawn by
1/4" = 1'-0"	SB. Alonway
des. #	rev
A-05	4



PRELIMINARY
NOT FOR CONSTRUCTION

General Notes :-
Do not scale this drawing.
Contractor to verify all dimensions on site and report any errors or omissions to the Designer in writing before work commences.
All drawings and specifications will remain the property of the Designer.
Copyright © 2004 of Adtek Building Consultants. All rights reserved.

no.	revisions	date
3	ISSUED FOR PERMITS	10/25/04
2	ISSUED FOR CLIENT REVIEW	09/28/04
1	ISSUED FOR CLIENT REVIEW	08/26/04

permit stamp

professional stamp

date

project

proposed new residence at
carmichael crescent,
blue mountain, ontario.
for mr. & mrs. calvert.

ADTEK BUILDING CONSULTANTS
ARCHITECTURAL DESIGN & SCIENCE LTD.
182 Cleveland Street, Toronto, Ontario, Canada, M6H 2Y9.
Tel: 416 593 3078, Fax: 416 592 1382, Cell: 416 591 0503.
Email: adtek@adtekbuilding.com
Web: http://www.adtekbuilding.com

date	June 28/04	project #	04/05-43
scale	1/4" = 1'-0"	drawn by	Bl. Abbrey
des. #	A-06	rev	3



PROPOSED SOUTH EAST ELEVATION.

Scale = 1/4" = 1'-0".



PROPOSED SOUTH WEST ELEVATION.

Scale = 1/4" = 1'-0".

General Notes :-
Do not scale this drawing.
Contractor to verify all dimensions on site and report any errors or omissions to the Designer in writing, before work commences.
All drawings and specifications will remain the property of the Designer.
Copyright © 2004 of Adtek Building Consultants. All rights reserved.

revision		
no.	revisions	date
3	ISSUED FOR PERMITS	10/26/04
2	ISSUED FOR CLIENT REVIEW	05/26/04
1	ISSUED FOR CLIENT REVIEW	04/29/04

permit stamp

professional stamp	north
	align


site
SOUTH EAST & SOUTH WEST ELEVATIONS AS PROPOSED.

project
PROPOSED NEW RESIDENCE AT CARMICHAEL CRESCENT, BLUE MOUNTAIN, ONTARIO, FOR MR. & MRS. CALVERT.

ADTEK BUILDING CONSULTANTS
ARCHITECTURAL DESIGN & DEVELOPMENT
382 Cleveland Street, Toronto, Ontario, Canada M4S 2R5
Tel: 416 592 3078 Fax: 416 592 1300 Cell: 416 571 9322
Email: design@adtekbldg.com Web: http://www.adtekbldg.com

date June 28/04	project # 04/0943
scale 1/4" = 1'-0"	drawn by B. Akbari
des. # A-07	rev 3

**PRELIMINARY
NOT FOR CONSTRUCTION**

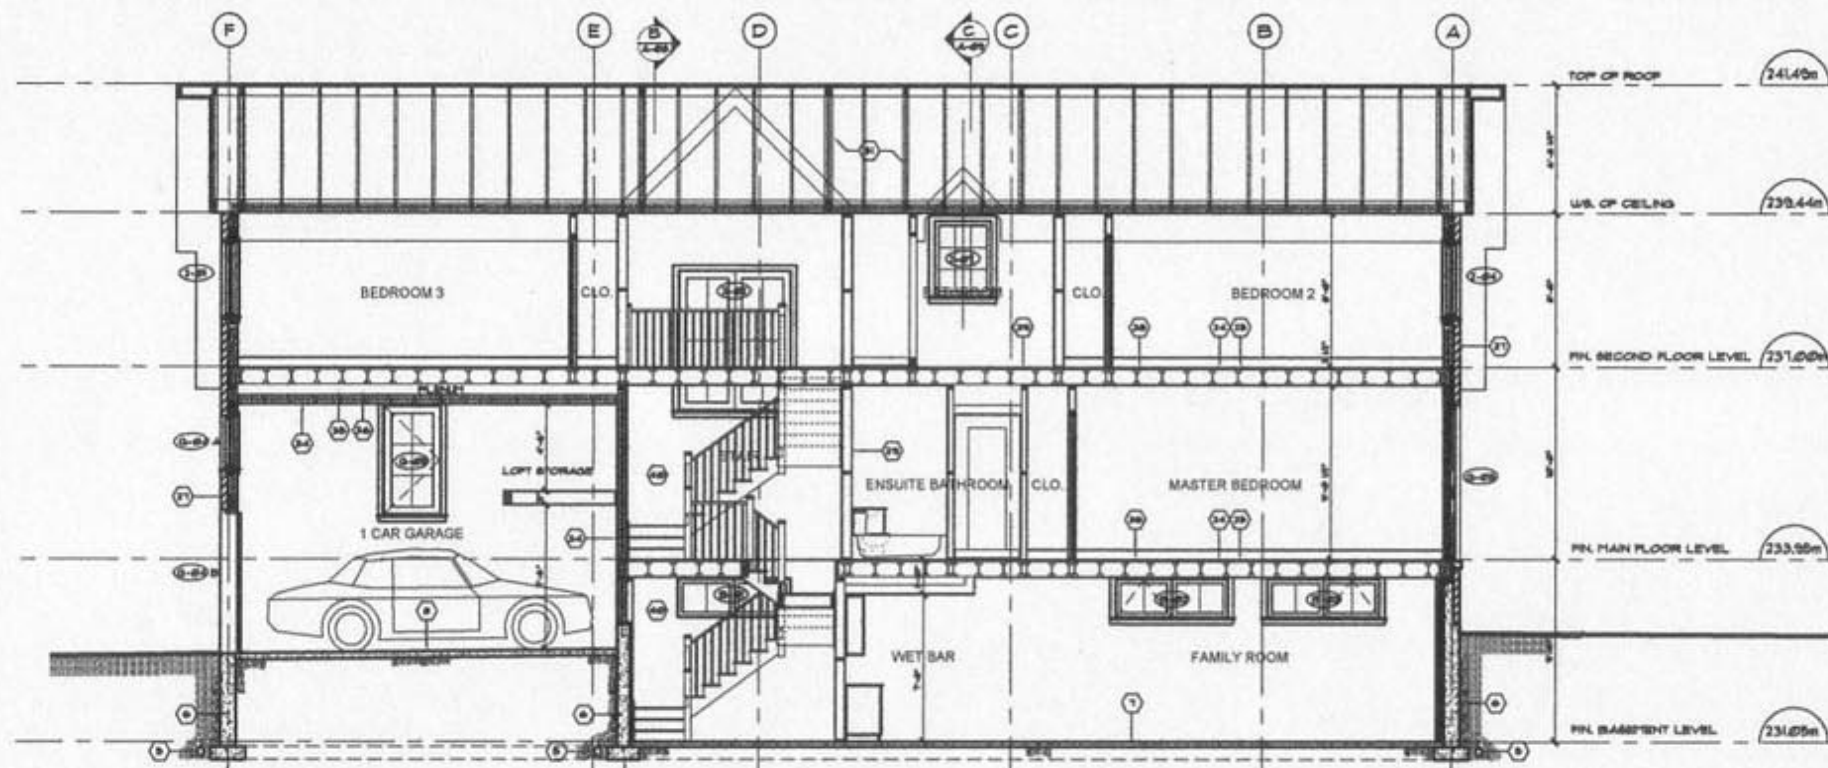

PROPOSED SECTION A-A.
Scale = 1/4" = 1'-0".



PROPOSED SECTION B-B
Scale = 1/4" = 1'-0".

PRELIMINARY
NOT FOR CONSTRUCTION

General Notes :-
Do not scale this drawing.
Contractor to verify all dimensions on site and report any errors or omissions to the Designer in writing before work commences.
All drawings and specifications will remain the property of the Designer.
Copyright © 2004 of Adtek Building Consultants. All rights reserved.

revisions		
no.	revisions	date
3	ISSUED FOR PERMIT	05/05/04
2	ISSUED FOR CLIENT REVIEW	04/04/04
1	ISSUED FOR CLIENT REVIEW	03/04/04

permit stamp


professional stamp	north
	signed

SECTION A-A & B-B
AS PROPOSED.

PROPOSED NEW
RESIDENCE AT
CARMICHAEL CRESCENT,
BLUE MOUNTAIN, ONTARIO.
FOR MR. & MRS. CALVERT.

ADTEK BUILDING CONSULTANTS
ARCHITECTURAL DESIGN & TECHNOLOGY
362 Cleveland Street, Toronto, Ontario, Canada, M4S 2Y8.
Tel: 416 503 8276, Fax: 416 503 1392, Cell: 416 571 6821.
Email: design@adtekbldg.com
Web: <http://www.adtekbldg.com>

date	July 25/04	project #	04/05-03
scale	1/4" = 1'-0"	drawn by	St. Abney
rev. #	A-08	rev	3

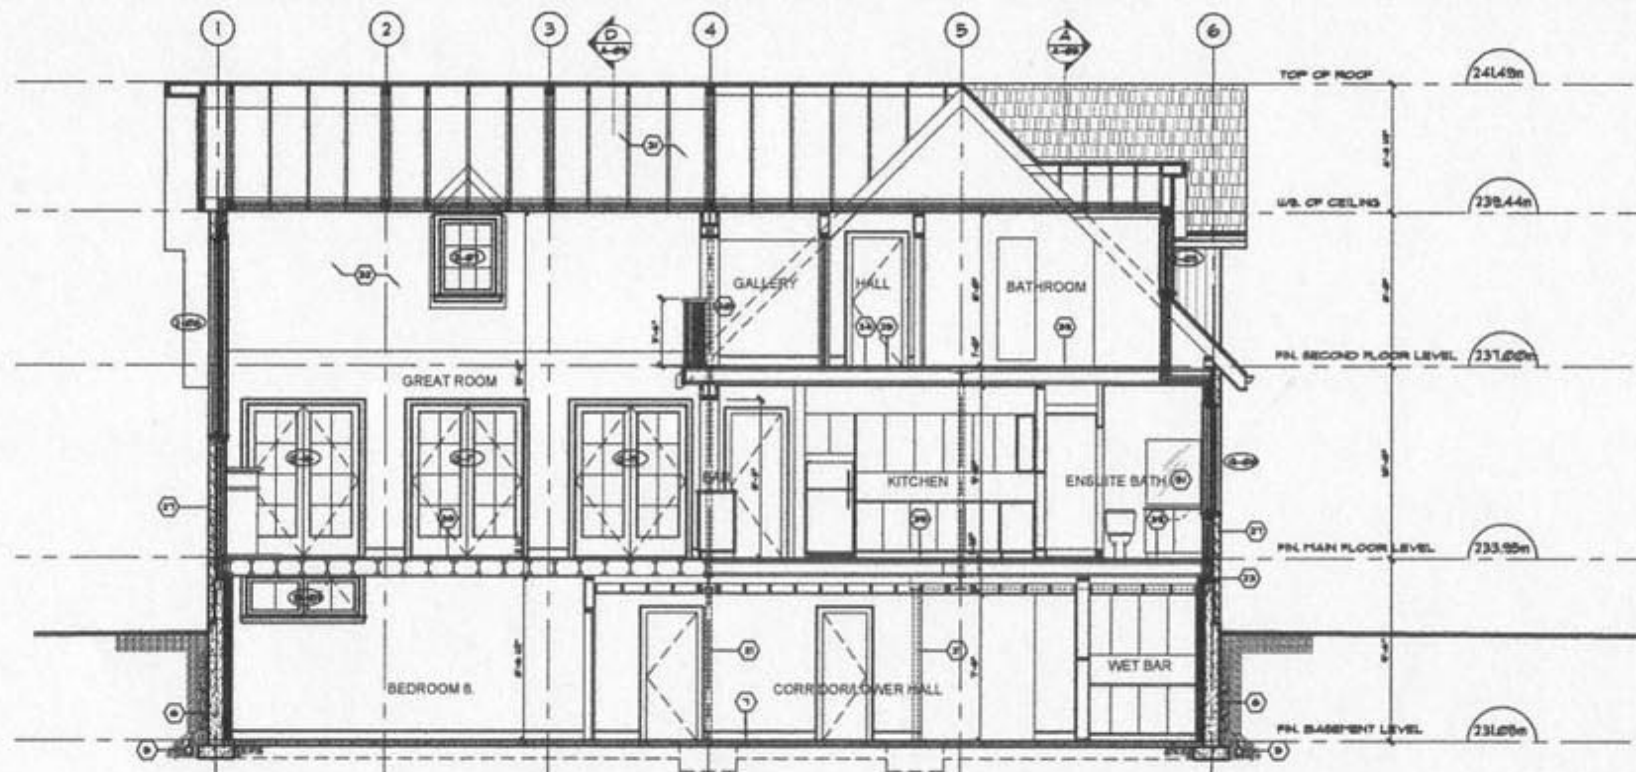

PROPOSED SECTION C-C.
Scale = 1/4" = 1'-0".



PROPOSED SECTION D-D.
Scale = 1/4" = 1'-0".

PRELIMINARY
NOT FOR CONSTRUCTION

General Notes:
Do not scale this drawing.
Contractor to verify all dimensions on site and report any errors or omissions to the Designer in writing before work commences.
All drawings and specifications shall remain the property of the Designer.
Copyright © 2004 of Adtek Building Consultants. All rights reserved.

revisions		
no.	revisions	date
1	ISSUED FOR PERMITS	08/25/04
2	ISSUED FOR CLIENT REVIEW	09/10/04

permit stamp

professional stamp

north


sign

SECTIONS C-C & D-D.
AS PROPOSED.

project
PROPOSED NEW RESIDENCE AT CARMICHAEL CRESCENT, BLUE MOUNTAIN, ONTARIO, FOR MR. & MRS. CALVERT.

ADTEK BUILDING CONSULTANTS
ARCHITECTURAL DESIGN & TECHNOLOGY
302 Cleveland Street, Toronto, Ontario, Canada, M4S 2P6
Tel: 416 593 3275, Fax: 416 593 1563, Cell: 416 591 0522
Email: enquiries@adtekbuilding.com
Web: <http://www.adtekbuilding.com>

date July 24/04	project # 04/05-43
scale 1/4" = 1'-0"	drawn by B. Alkomy
des. # A-03	rev 2

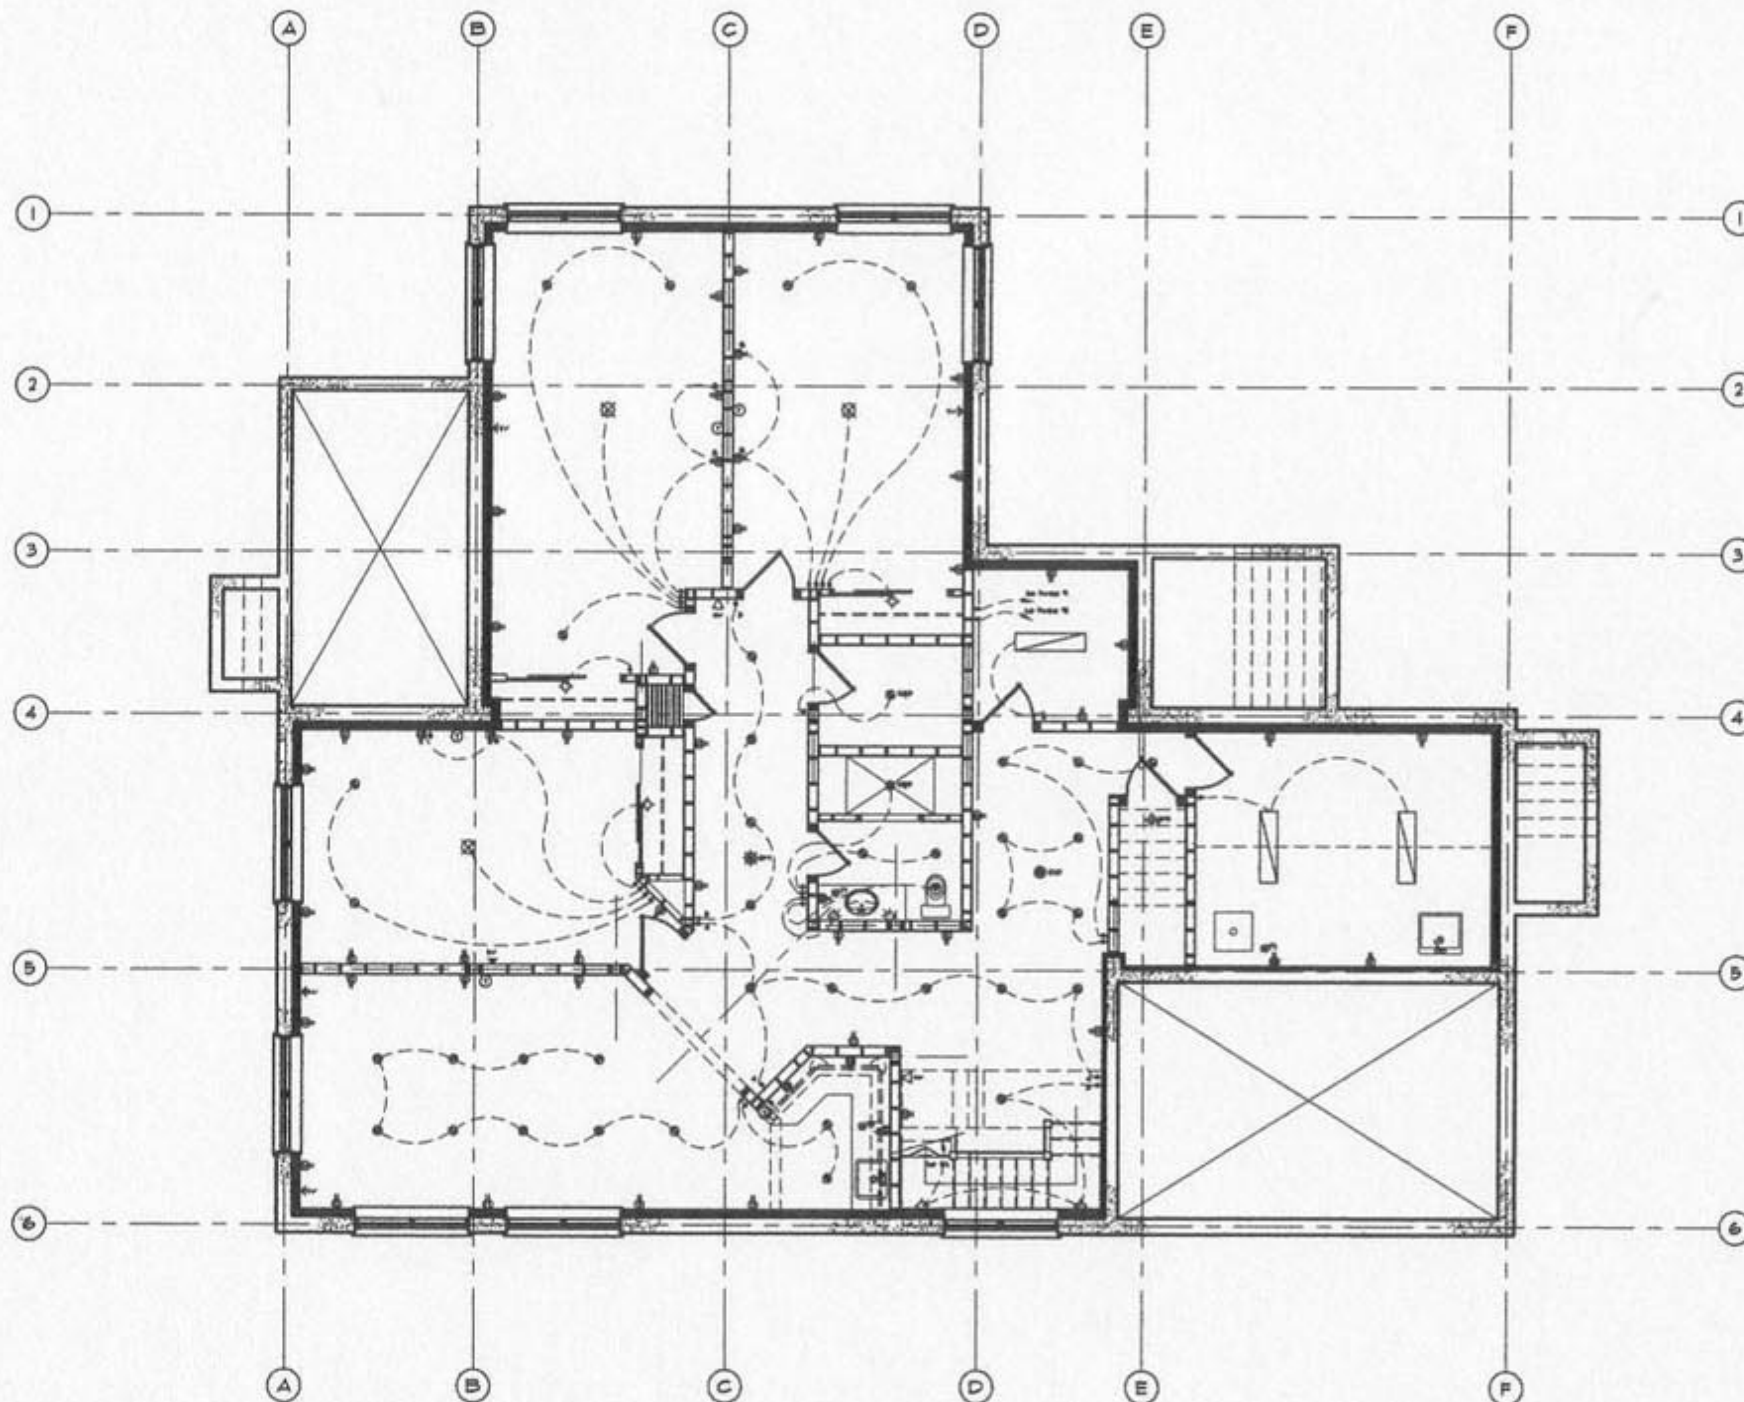

PROPOSED BASEMENT ELECTRICAL PLAN.
Scale = 1/4" = 1'-0".

Electrical Legend

- ⊙ CO Carbon Monoxide Detector
- ⊙ SD Smoke Detector
- ⊙ MF Mechanical Fan
- ⊙ LF Lights Fixture - Ceiling Mounted
- ⊙ LF Lights Fixture - Wall Mounted
- ⊙ LF Lights Fixture - Wall Washer
- ⊙ LF Lights Fixture - Pull Chain
- ⊙ LF Lights Fixture - Recessed Pot
- ⊙ LF Undercabinet Fluorescent Fixture
- ⊙ LF Undercabinet Microwave Hood
- ⊙ LF 2' x 4' Fluorescent Fixture
- ⊙ LF 1' x 4' Fluorescent Fixture
- ⊙ S Switch
- ⊙ 3S 3-way Switch
- ⊙ 4S 4-way Switch
- ⊙ T Timer
- ⊙ DT Dimmer
- ⊙ GDO Garage Door Opener
- ⊙ SC Split Circuit
- ⊙ DO Duplex Outlet - 12"
- ⊙ DO Duplex Outlet - 42"
- ⊙ PO Picture Outlet - 12"
- ⊙ GPO Ground Fault Outlet
- ⊙ DO Dishwasher Outlet
- ⊙ WDO Weatherproof Duplex Outlet
- ⊙ HDO Heavy Duty Outlet - 220V/20amp
- ⊙ FMO Floor Mounted Outlet
- ⊙ CDO Computer Dedicated Outlet
- ⊙ CDO Computer Dedicated Floor Mounted Outlet
- ⊙ HL Heat Lamp - Ceiling Fixture
- ⊙ CV Central Vacuum
- ⊙ TC Television Cable
- ⊙ TJ Telephone Jack
- ⊙ DC Door Chime
- ⊙ T Thermostat

Note: Centre all ceiling fixtures unless otherwise specified.
Electrical must not be roughed in less than 6" from rough openings or corners unless site approved by Designer.

NOTE:-

All interior recessed pot lights to be 5" diam. halogen. Fixtures to be selected by Client.

All exterior recessed pot lights to be 7" diam. incandescent. Fixtures to be selected by Client.

General Notes :-
Do not scale this drawing.
Contractor to verify all dimensions on site and report any errors or omissions to the Designer in writing before work commences.
All drawings and specifications shall remain the property of the Designer.
Copyright © 2004 of Adtek Building Consultants. All rights reserved.

no.	revisions	date
1	ISSUED FOR PERMITS	10/15/04
2	ISSUED FOR REVIEW	10/15/04

permit stamp	
architectural stamp	
North	align


BASEMENT ELECTRICAL PLAN AS PROPOSED

project
PROPOSED NEW RESIDENCE AT CARMICHAEL CRESCENT, BLUE MOUNTAIN, ONTARIO, FOR MR. & MRS. CALVERT.

ADTEK BUILDING CONSULTANTS
ARCHITECTURAL DESIGN & TECHNOLOGY
162 Cleveland Street, Toronto, Ontario, Canada, M5S 2W5
Tel: 416 592 5275, Fax: 416 592 1165, Cell: 416 571 8252
Email: adtek@adtekbldg.com
Web: http://www.adtekbldg.com

date	project #
Sept. 10/04	04-09-43
scale	drawn by
1/4" = 1'-0"	B. Alkaway
rev. #	rev
E-01	1

PRELIMINARY
NOT FOR CONSTRUCTION

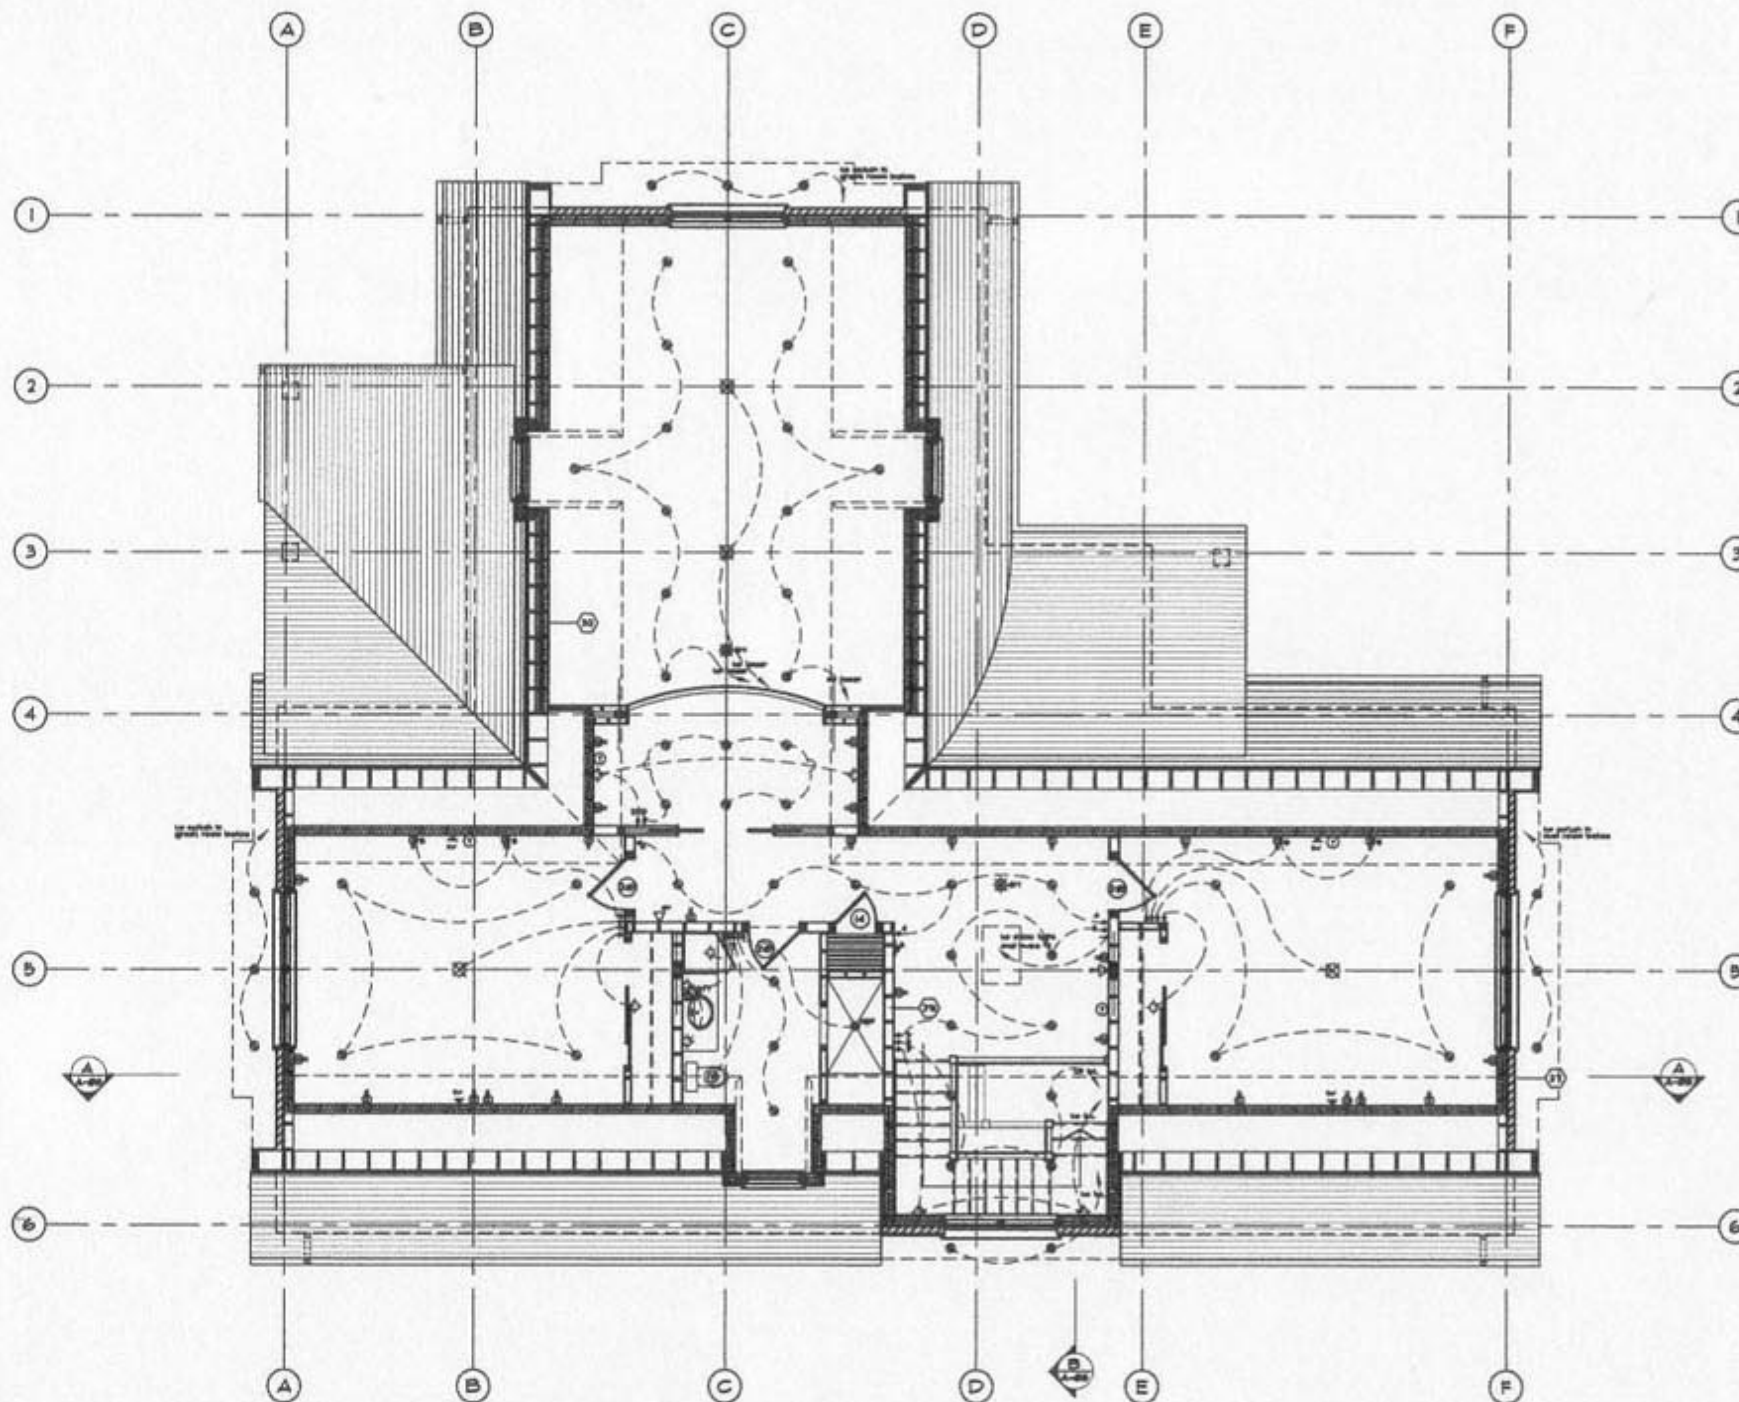

PROPOSED SECOND FLOOR ELECTRICAL PLAN..
Scale = 1/4" = 1'-0".

Electrical Legend

- ⊙ CO Carbon Monoxide Detector
- ⊙ SD Smoke Detector
- ⊙ MF Mechanical Fan
- ⊙ LM Light Fixture - Ceiling Mounted
- ⊙ WM Light Fixture - Wall Mounted
- ⊙ WL Light Fixture - Wall Washer
- ⊙ PC Light Fixture - Pull Chain
- ⊙ RP Light Fixture - Recessed Pot
- ⊙ UF Undercabinet Fluorescent Fixture
- ⊙ MH Undercabinet Microwave Hood
- ⊙ 2' x 4' Fluorescent Fixture
- ⊙ 1' x 4' Fluorescent Fixture
- ⊙ S Switch
- ⊙ 3S 3-way Switch
- ⊙ 4S 4-way Switch
- ⊙ T Timer
- ⊙ D Dimmer
- ⊙ GDO Garage Door Opener
- ⊙ SC Split Circuit
- ⊙ DO Duplex Outlet # 12"
- ⊙ DO Duplex Outlet # 42"
- ⊙ PO Picture Outlet # 12"
- ⊙ GFO Ground Fault Outlet
- ⊙ DO Dishwasher Outlet
- ⊙ WDO Weatherproof Duplex Outlet
- ⊙ HDO Heavy Duty Outlet 250V/30amp
- ⊙ FMO Floor Mounted Outlet
- ⊙ CDO Computer Dedicated Outlet
- ⊙ CDO Computer Dedicated Floor Mounted Outlet
- ⊙ HL Heat Lamp - Ceiling Fixture
- ⊙ CV Central Vacuum
- ⊙ TC Television Cable
- ⊙ TJ Telephone Jack
- ⊙ DO Door Chimes
- ⊙ T Thermostat


Note:
Centre all ceiling fixtures unless otherwise specified.
Electrical must not be roughed in less than 6" from rough openings or corners unless site approved by Designer.

NOTE:
All interior recessed pot lights to be 5" diam. halogen. Fixtures to be selected by Client.
All exterior recessed pot lights to be 7" diam. incandescent. Fixtures to be selected by Client.

General Notes:
Do not scale this drawing.
Contractor to verify all dimensions on site and report any errors or omissions to the Designer in writing before work commences.
All drawings and specifications will remain the property of the Designer.
Copyright © 2004 of Adtek Building Consultants. All rights reserved.

Revisions		
no.	revisions	date
1	ISSUED FOR PERMITS	10/10/04
2	ISSUED FOR REVIEW	10/10/04

permit stamp

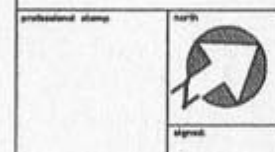

SECOND FLOOR ELECTRICAL PLAN AS PROPOSED

PROJECT
PROPOSED NEW RESIDENCE AT CARMICHAEL CRESCENT, BLUE MOUNTAIN, ONTARIO, FOR MR. & MRS. CALVERT.

ADTEK BUILDING CONSULTANTS
ARCHITECTURAL DESIGN & TECHNOLOGY
360 Cleveland Street, Toronto, Ontario, Canada, M4E 2W5
Tel: 416 592 5275, Fax: 416 592 1005, Cell: 416 571 5222
Email: info@adtekbldg.com
Web: http://www.adtekbldg.com

date	06/01/04	project #	04-050-43
scale	1/4" = 1'-0"	drawn by	B. Alibek
dep. #	E-03	rev	

PRELIMINARY
NOT FOR CONSTRUCTION